


| REVISIONS |             |      |
|-----------|-------------|------|
| REV. NO.  | DESCRIPTION | DATE |
|           |             |      |

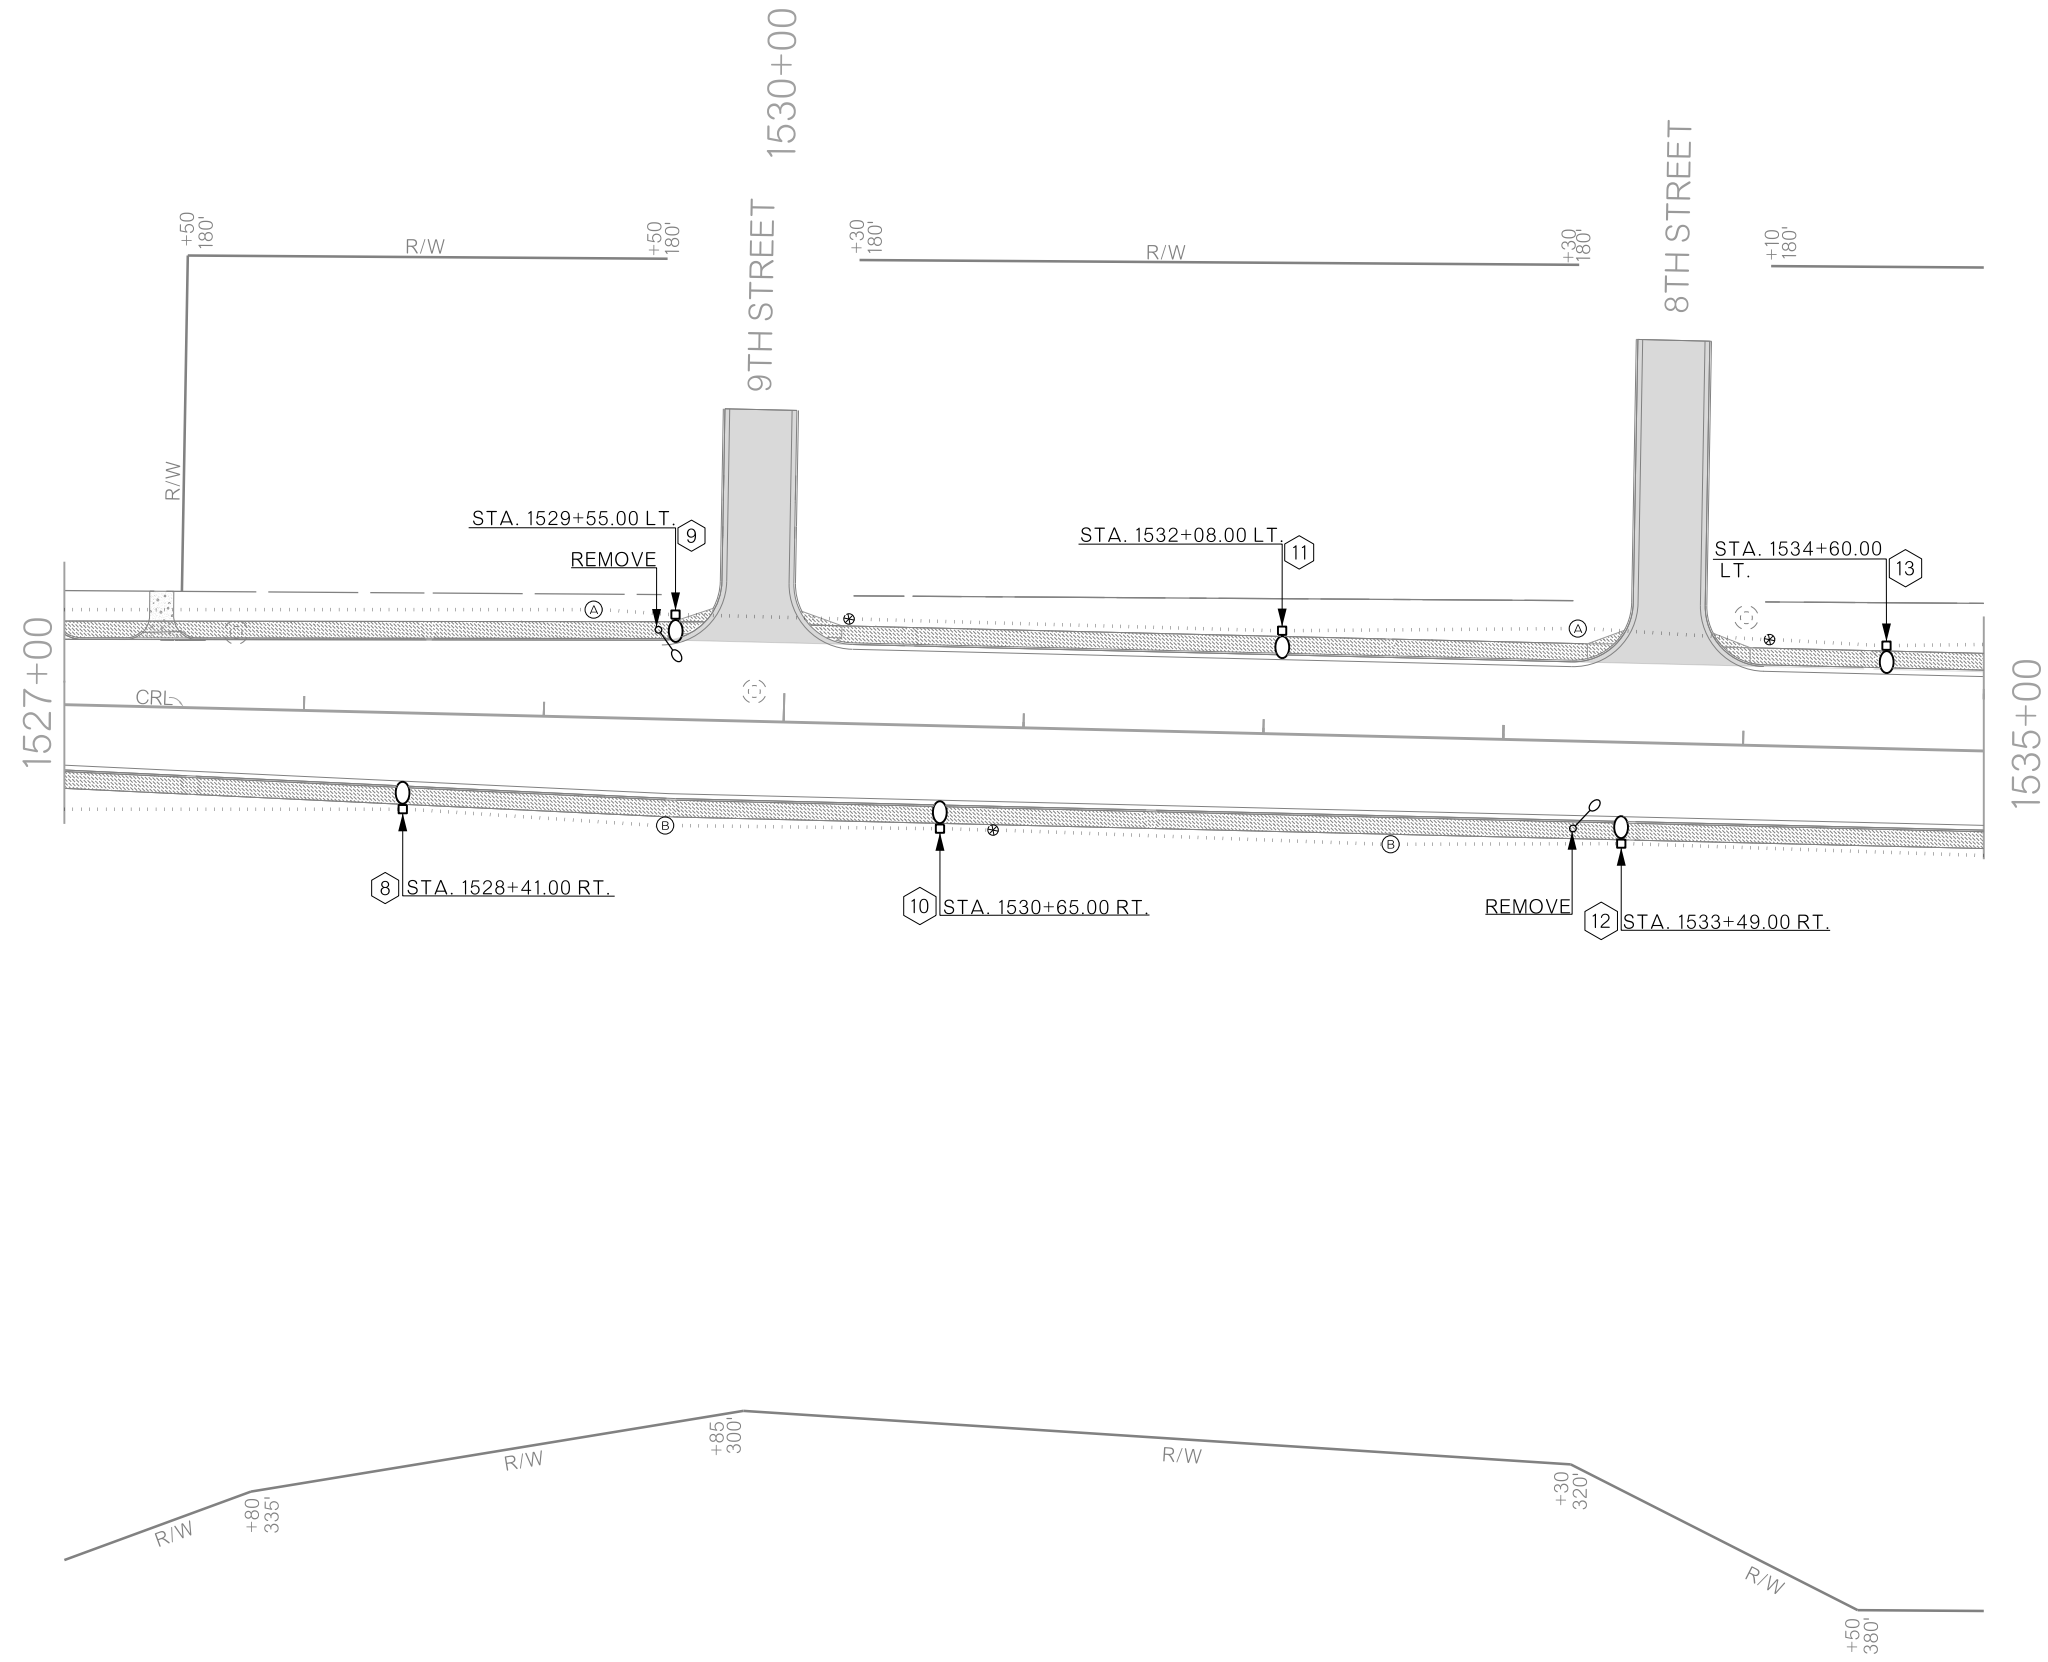

**LIGHTING LEGEND**

- ⊕ SIZE I PULL BOX
- 400W LED LUMINAIRE, 40' MTG. HT. POLE NON-BREAKAWAY BASE AND FOOTING
- 400W LED LUMINAIRE, 40' MTG. HT. POLE BREAKAWAY BASE AND FOOTING
- ▲ NEW SERVICE POLE
- Ⓐ CIRCUIT IDENTIFICATION
- 1-1/4" GALV. STL. ELECT. CONDUIT EXPOSED (UNLESS OTHERWISE SPECIFIED)
- ..... 2" PVC ELECT. CONDUIT TRENCHED WITH TWO NO. 4 AWG CONDUCTORS (UNLESS OTHERWISE SPECIFIED)
- - - 2" ELECT. CONDUIT PUSHED OR BORED WITH TWO NO. 4 AWG CONDUCTORS (UNLESS OTHERWISE SPECIFIED)
- ⊕ EXISTING LIGHT POLE

|                                      |         |     |      |
|--------------------------------------|---------|-----|------|
| <b>LIGHTING PLAN</b>                 | Drawn   | JF  | 3/16 |
|                                      | Design  | JF  | 3/16 |
|                                      | Checked | KCD | 7/16 |
| TRAFFIC ENGINEERING<br>TAREK MAAROUF |         |     |      |

|                          |                                     |
|--------------------------|-------------------------------------|
| <b>STATE OF OKLAHOMA</b> | <b>DEPARTMENT OF TRANSPORTATION</b> |
| DIVISION 4               | JOB/PIECE NO. 21860(04)             |
| SHEET NO. T013           | DATE                                |