


REVISIONS		
REV. NO.	DESCRIPTION	DATE

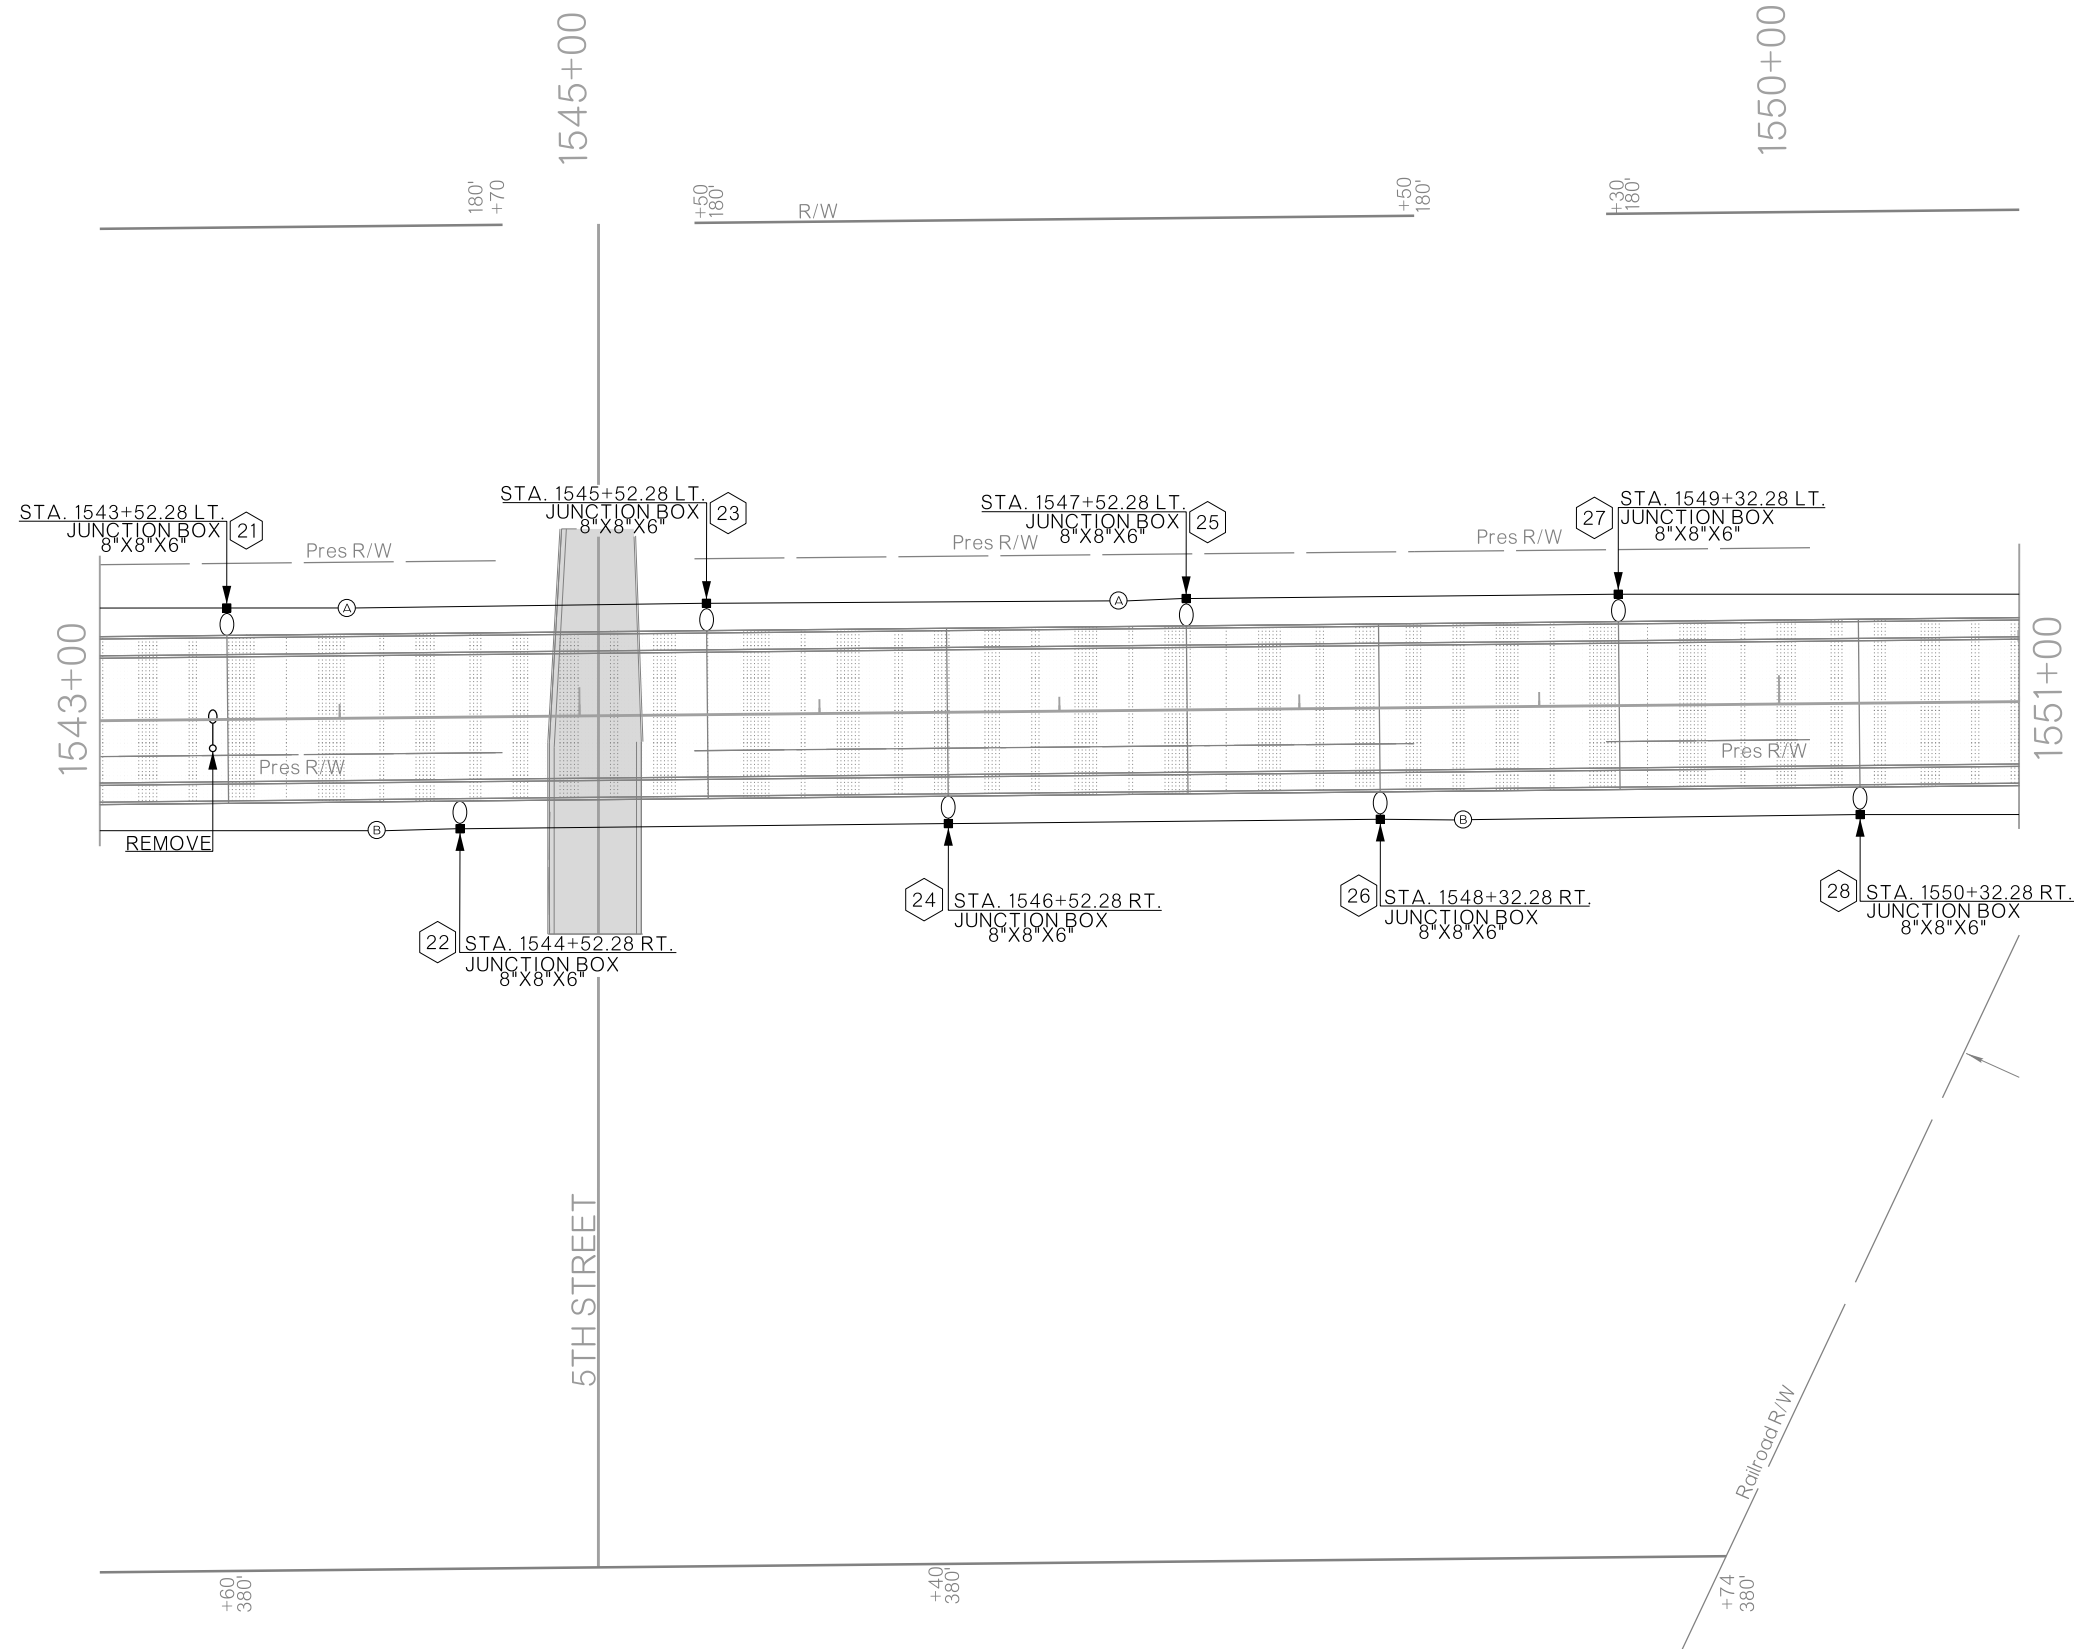

LIGHTING LEGEND

- JUNCTION BOX 8"x8"x6"
- ⊕ SIZE I PULL BOX
- 400W LED LUMINAIRE, 40' MTG. HT. POLE NON-BREAKAWAY BASE AND FOOTING
- 400W LED LUMINAIRE, 40' MTG. HT. POLE BREAKAWAY BASE AND FOOTING
- ▲ NEW SERVICE POLE
- Ⓐ CIRCUIT IDENTIFICATION
- 1-1/4" GALV. STL. ELECT. CONDUIT EXPOSED (UNLESS OTHERWISE SPECIFIED)
- 2" PVC ELECT. CONDUIT TRENCHED WITH TWO NO. 4 AWG CONDUCTORS (UNLESS OTHERWISE SPECIFIED)
- 2" ELECT. CONDUIT PUSHED OR BORED WITH TWO NO. 4 AWG CONDUCTORS (UNLESS OTHERWISE SPECIFIED)
- EXISTING LIGHT POLE

LIGHTING PLAN	Drawn	JF	3/16
	Design	JF	3/16
	Checked	KCD	7/16
	TRAFFIC ENGINEERING TAREK MAAROUF		

STATE OF OKLAHOMA	DIVISION 4	DEPARTMENT OF TRANSPORTATION	JOB/PIECE NO. 21860(04)	SHEET NO. T015
-------------------	------------	------------------------------	-------------------------	----------------