
 


OKLAHOMA DEPARTMENT OF TRANSPORTATION				
FED. ROAD DIST. NO.	STATE	PROJ. NO.	FISCAL YEAR	SHEET NO. TOTAL SHEETS
	OKLA.			
DESCRIPTION		REVISIONS		DATE


T-15-N
R-19-E

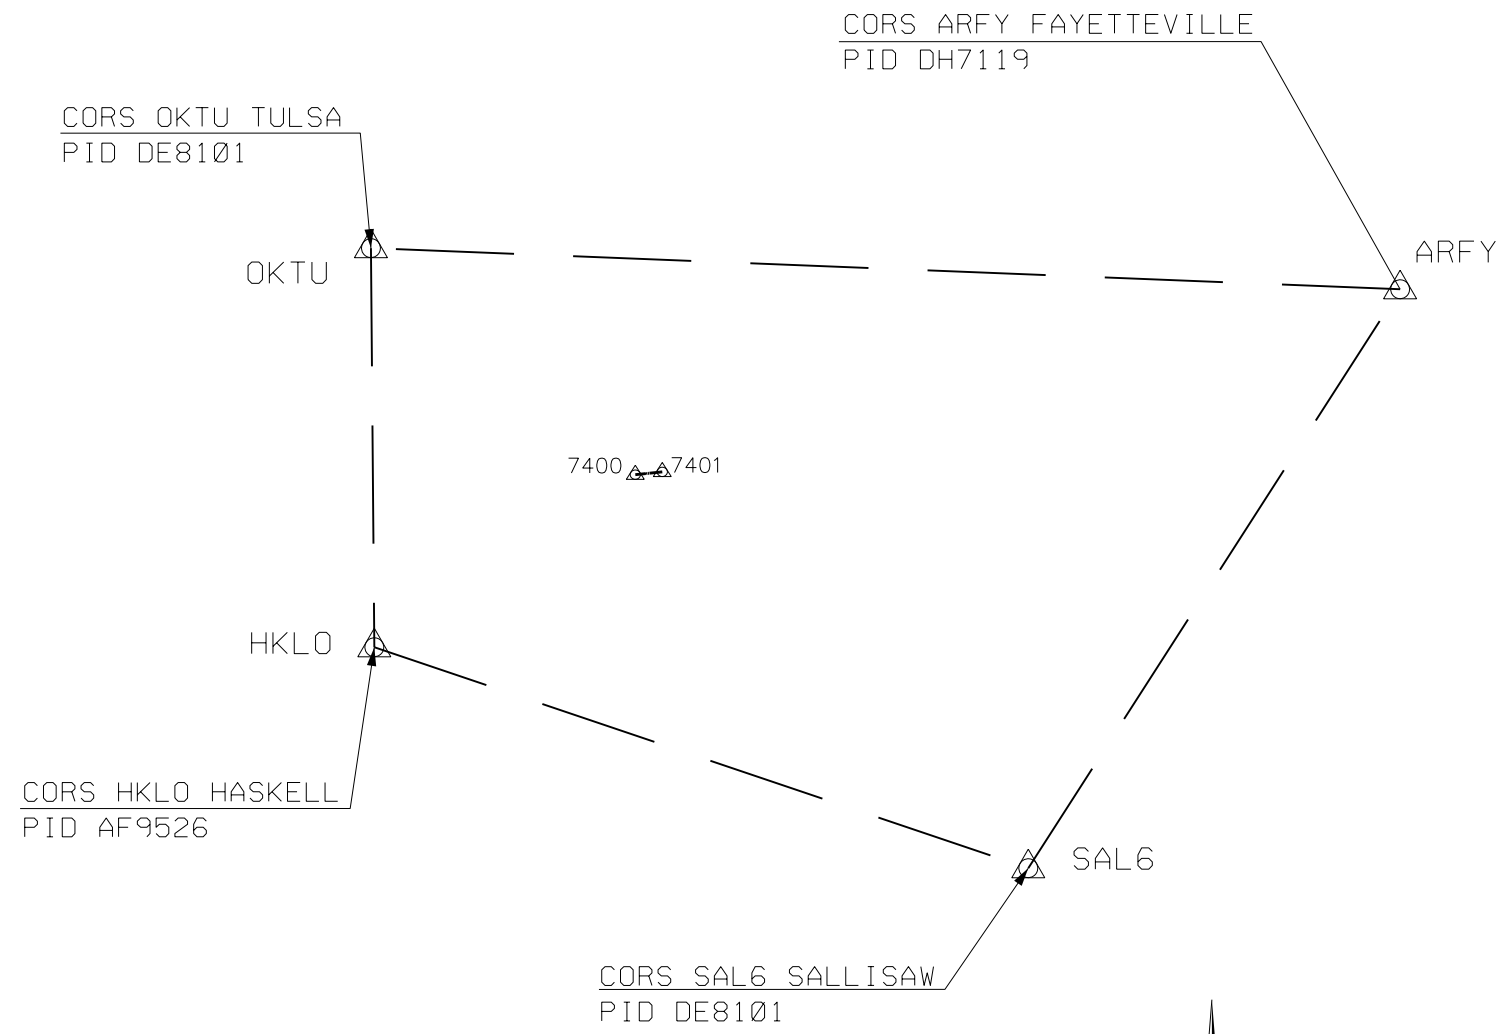

UTILIZED CORS STATIONS
N.T.S.



SCALE
N.T.S.

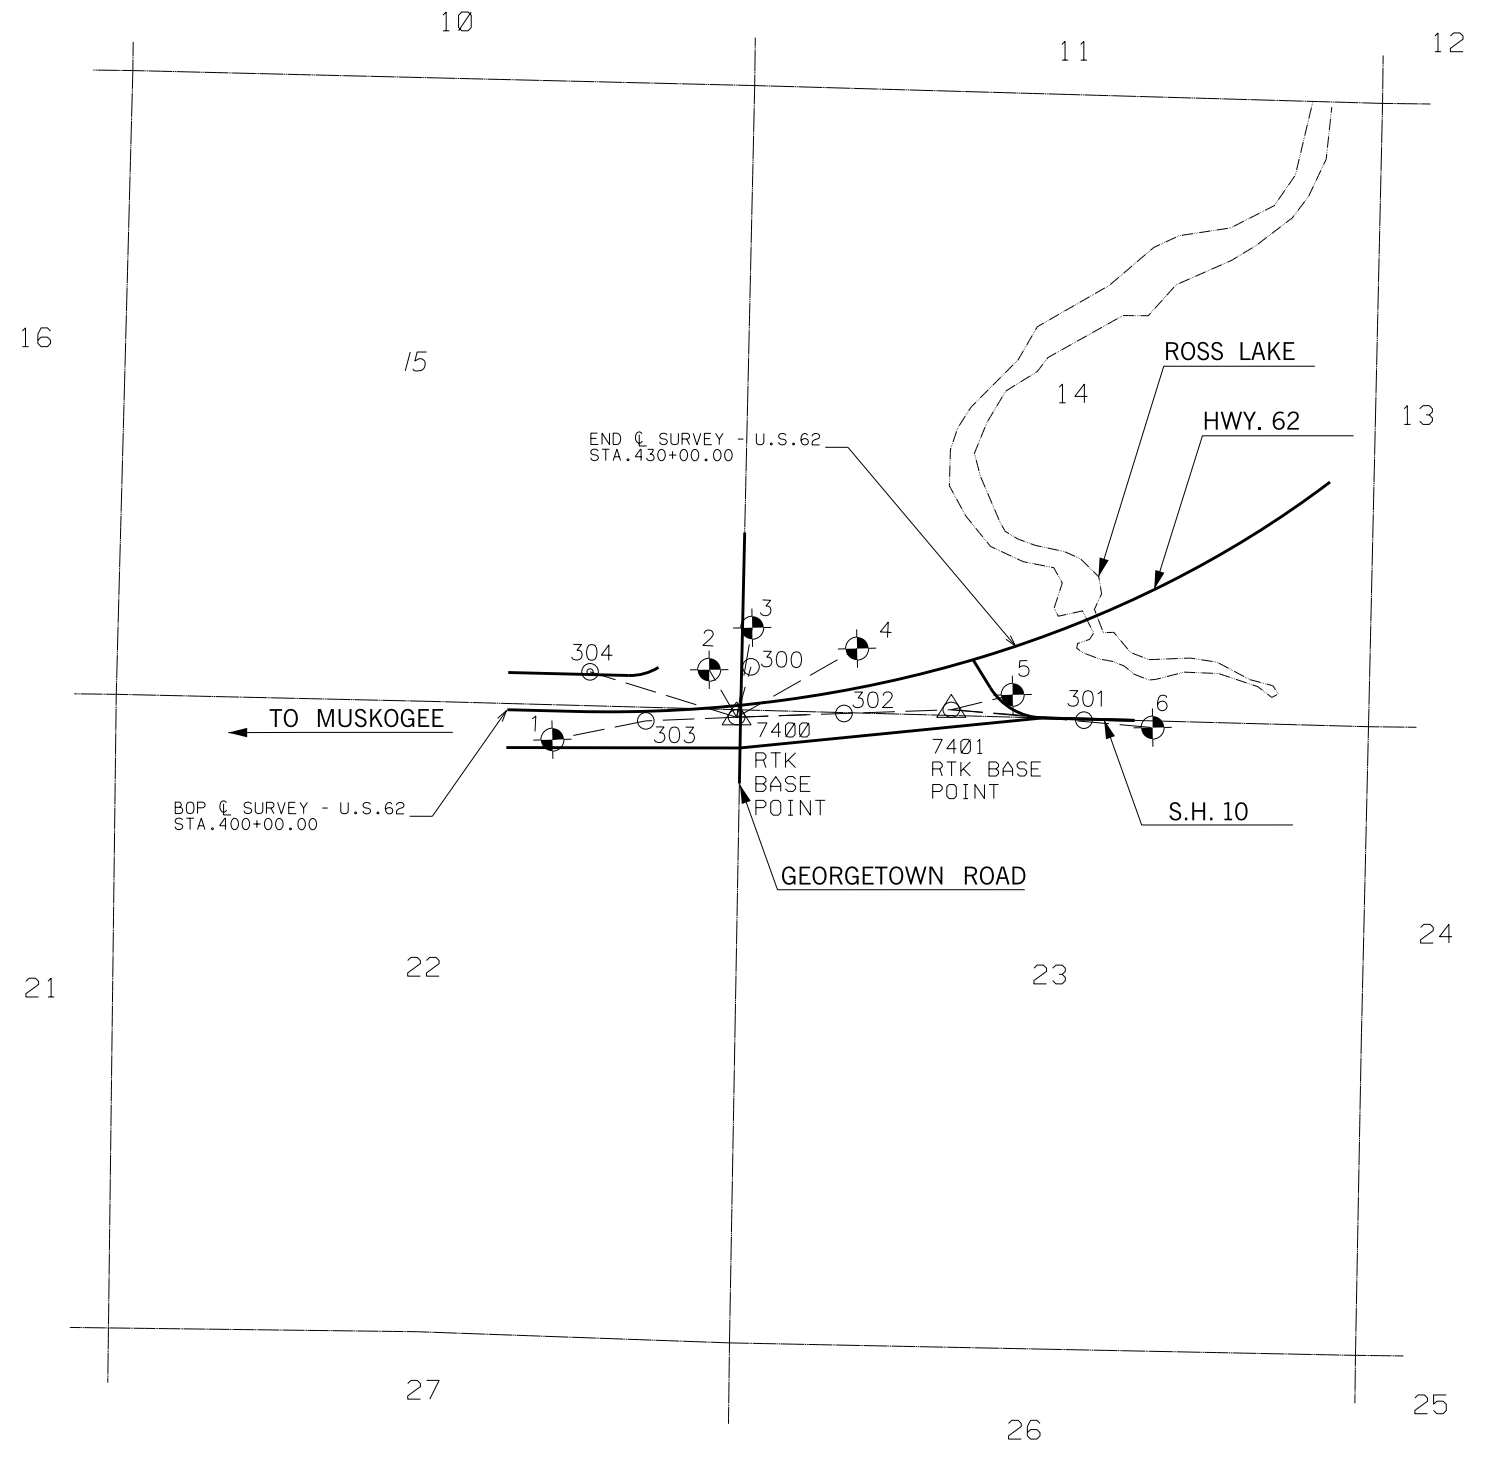

HORIZONTAL CONTROL DIAGRAM
N.T.S.

PLS	RLJ		OKLAHOMA DEPARTMENT OF TRANSPORTATION SURVEY DIVISION
DRAWN	JAJ		
CHECKED	PED		
APPROVED	RLJ		
CREW	RJ, WW, LL, DN	SWO	
			SURVEY DATA SHEET
			4889 () PROJECT NO. 27956(04) SHEET NO. 22