 



OKLAHOMA DEPARTMENT OF TRANSPORTATION					
FED. ROAD DIST. NO.	STATE	JOB PIECE NO.	FISCAL YEAR	SHEET NO.	TOTAL SHEETS
6	OKLA.	21899(04)			
DESCRIPTION			REVISIONS	DATE	



NOTE:
REFER TO ELECTRICAL SCHEDULES AND NOTES SHEET FOR FIXTURE LOCATION TABLE AND PLAN NOTES.

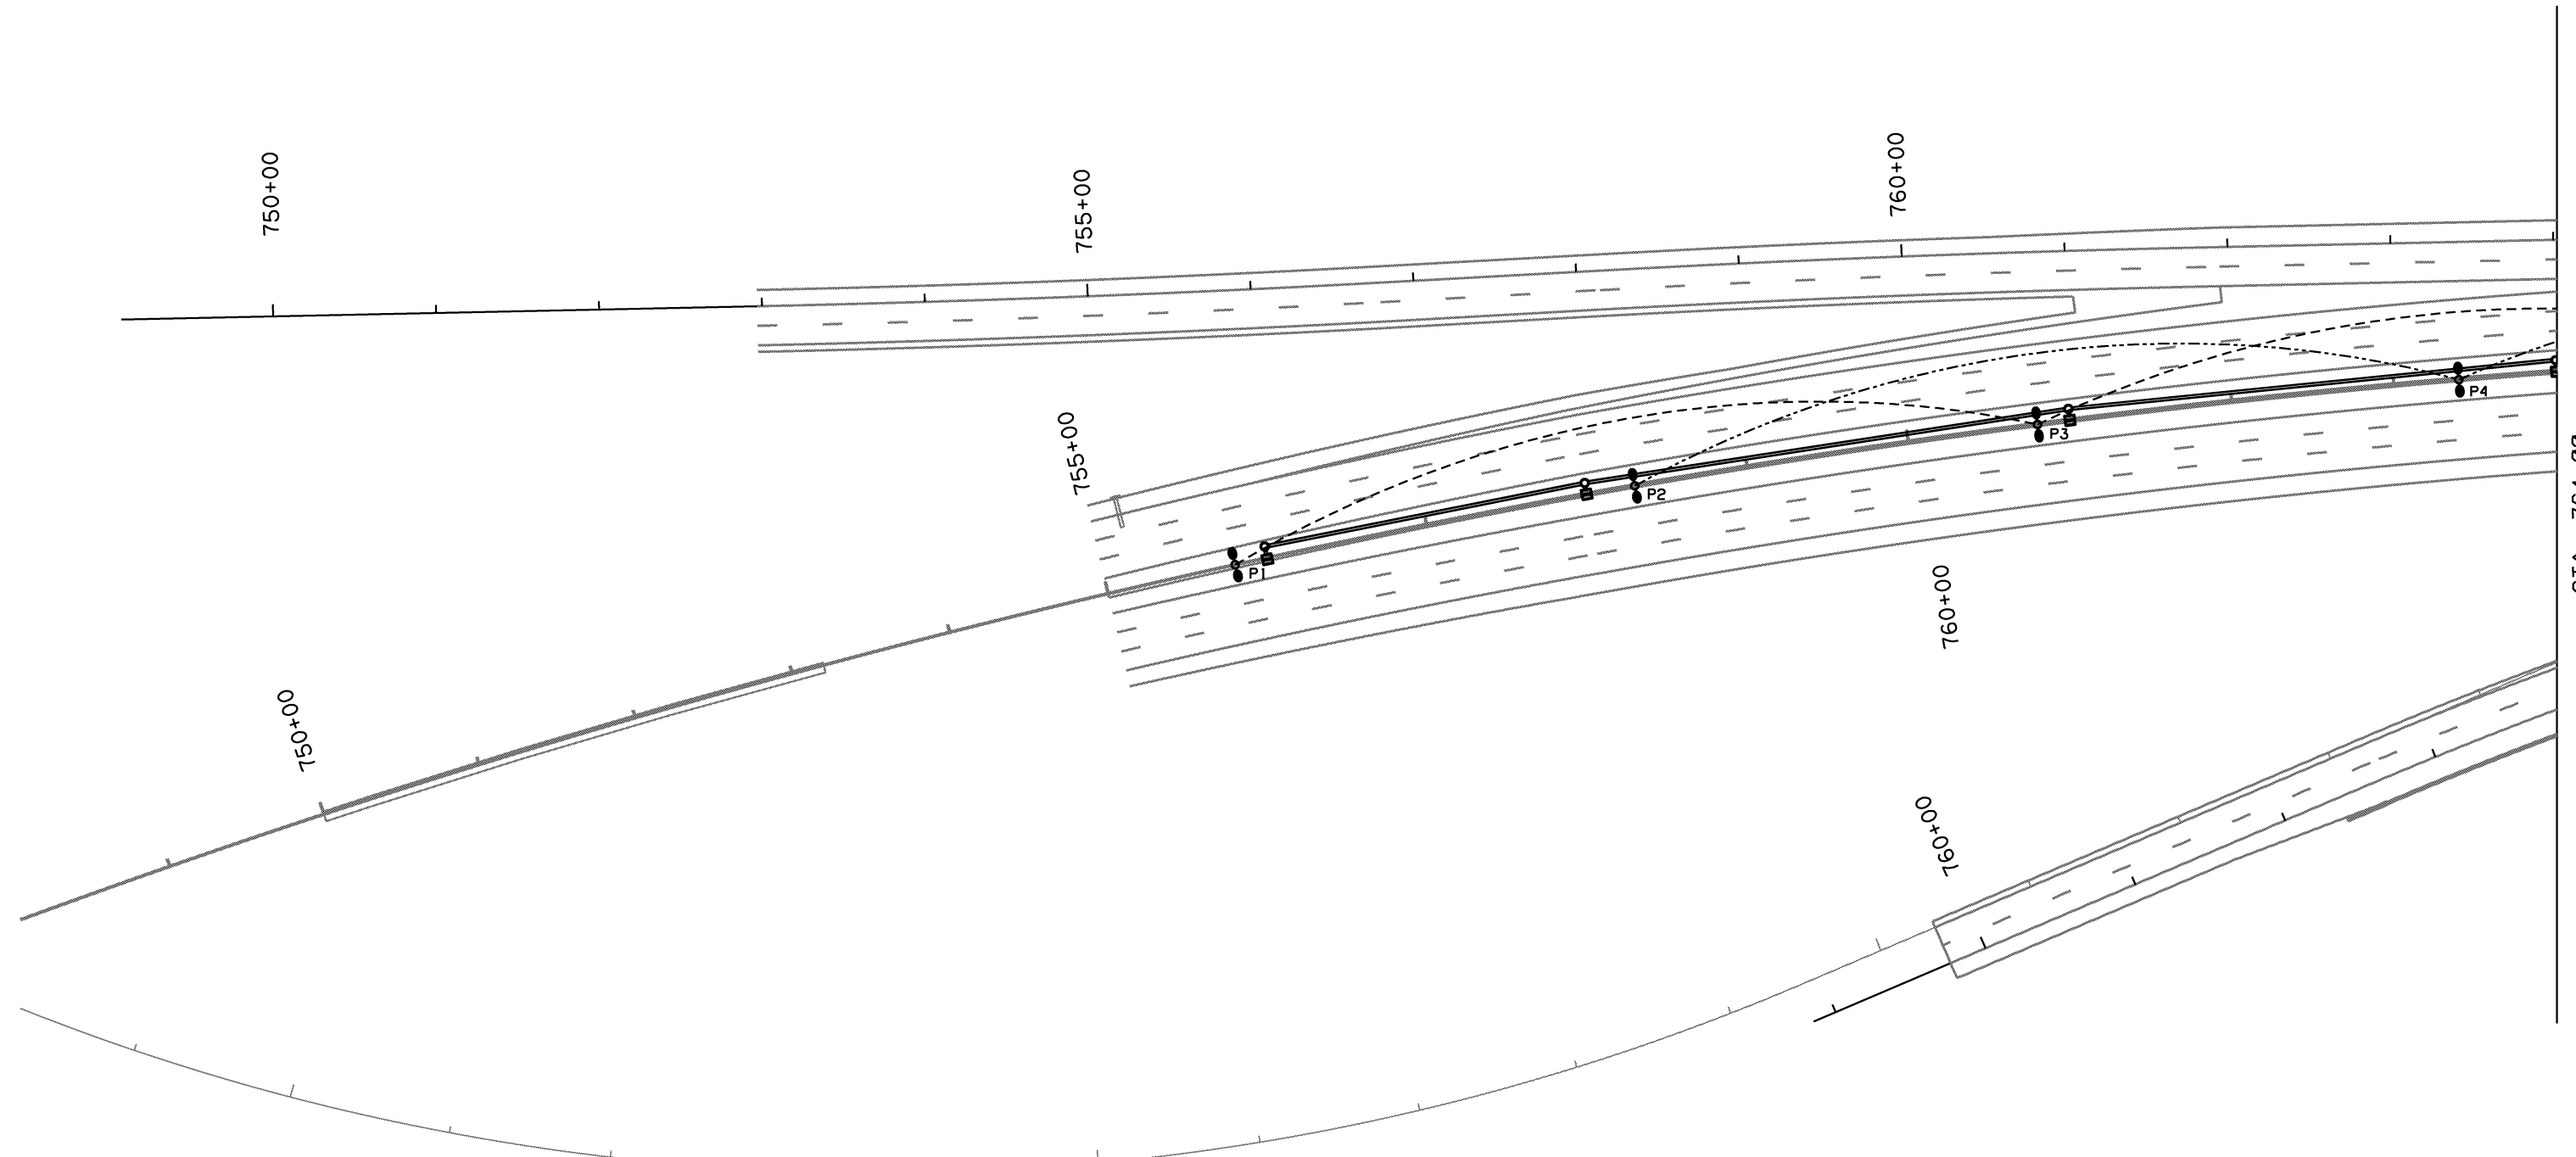

LEGEND	
---	CIRCUIT 'A' - WEST OF CENTER
---	CIRCUIT 'B' - WEST OF CENTER

DESIGN	SFF	2/15	TULSA & ROGERS COUNTIES
DRAWN	SFF	2/15	MEDIAN LIGHTING LAYOUT PLANS (SHEET 1 OF 5)
CHECKED	SFF	2/15	
APPROVED			
SQUAD	GARVER	STATE JOB NO. 21899(04)	SHEET NO. 213