 



OKLAHOMA DEPARTMENT OF TRANSPORTATION						
FED. ROAD DIST. NO.	STATE	JOB PIECE NO.	FISCAL YEAR	SHEET NO.	TOTAL SHEETS	
6	OKLA.	21899(04)				
DESCRIPTION			REVISIONS	DATE		



NOTE:
REFER TO ELECTRICAL SCHEDULES AND NOTES SHEET FOR FIXTURE LOCATION TABLE AND PLAN NOTES.

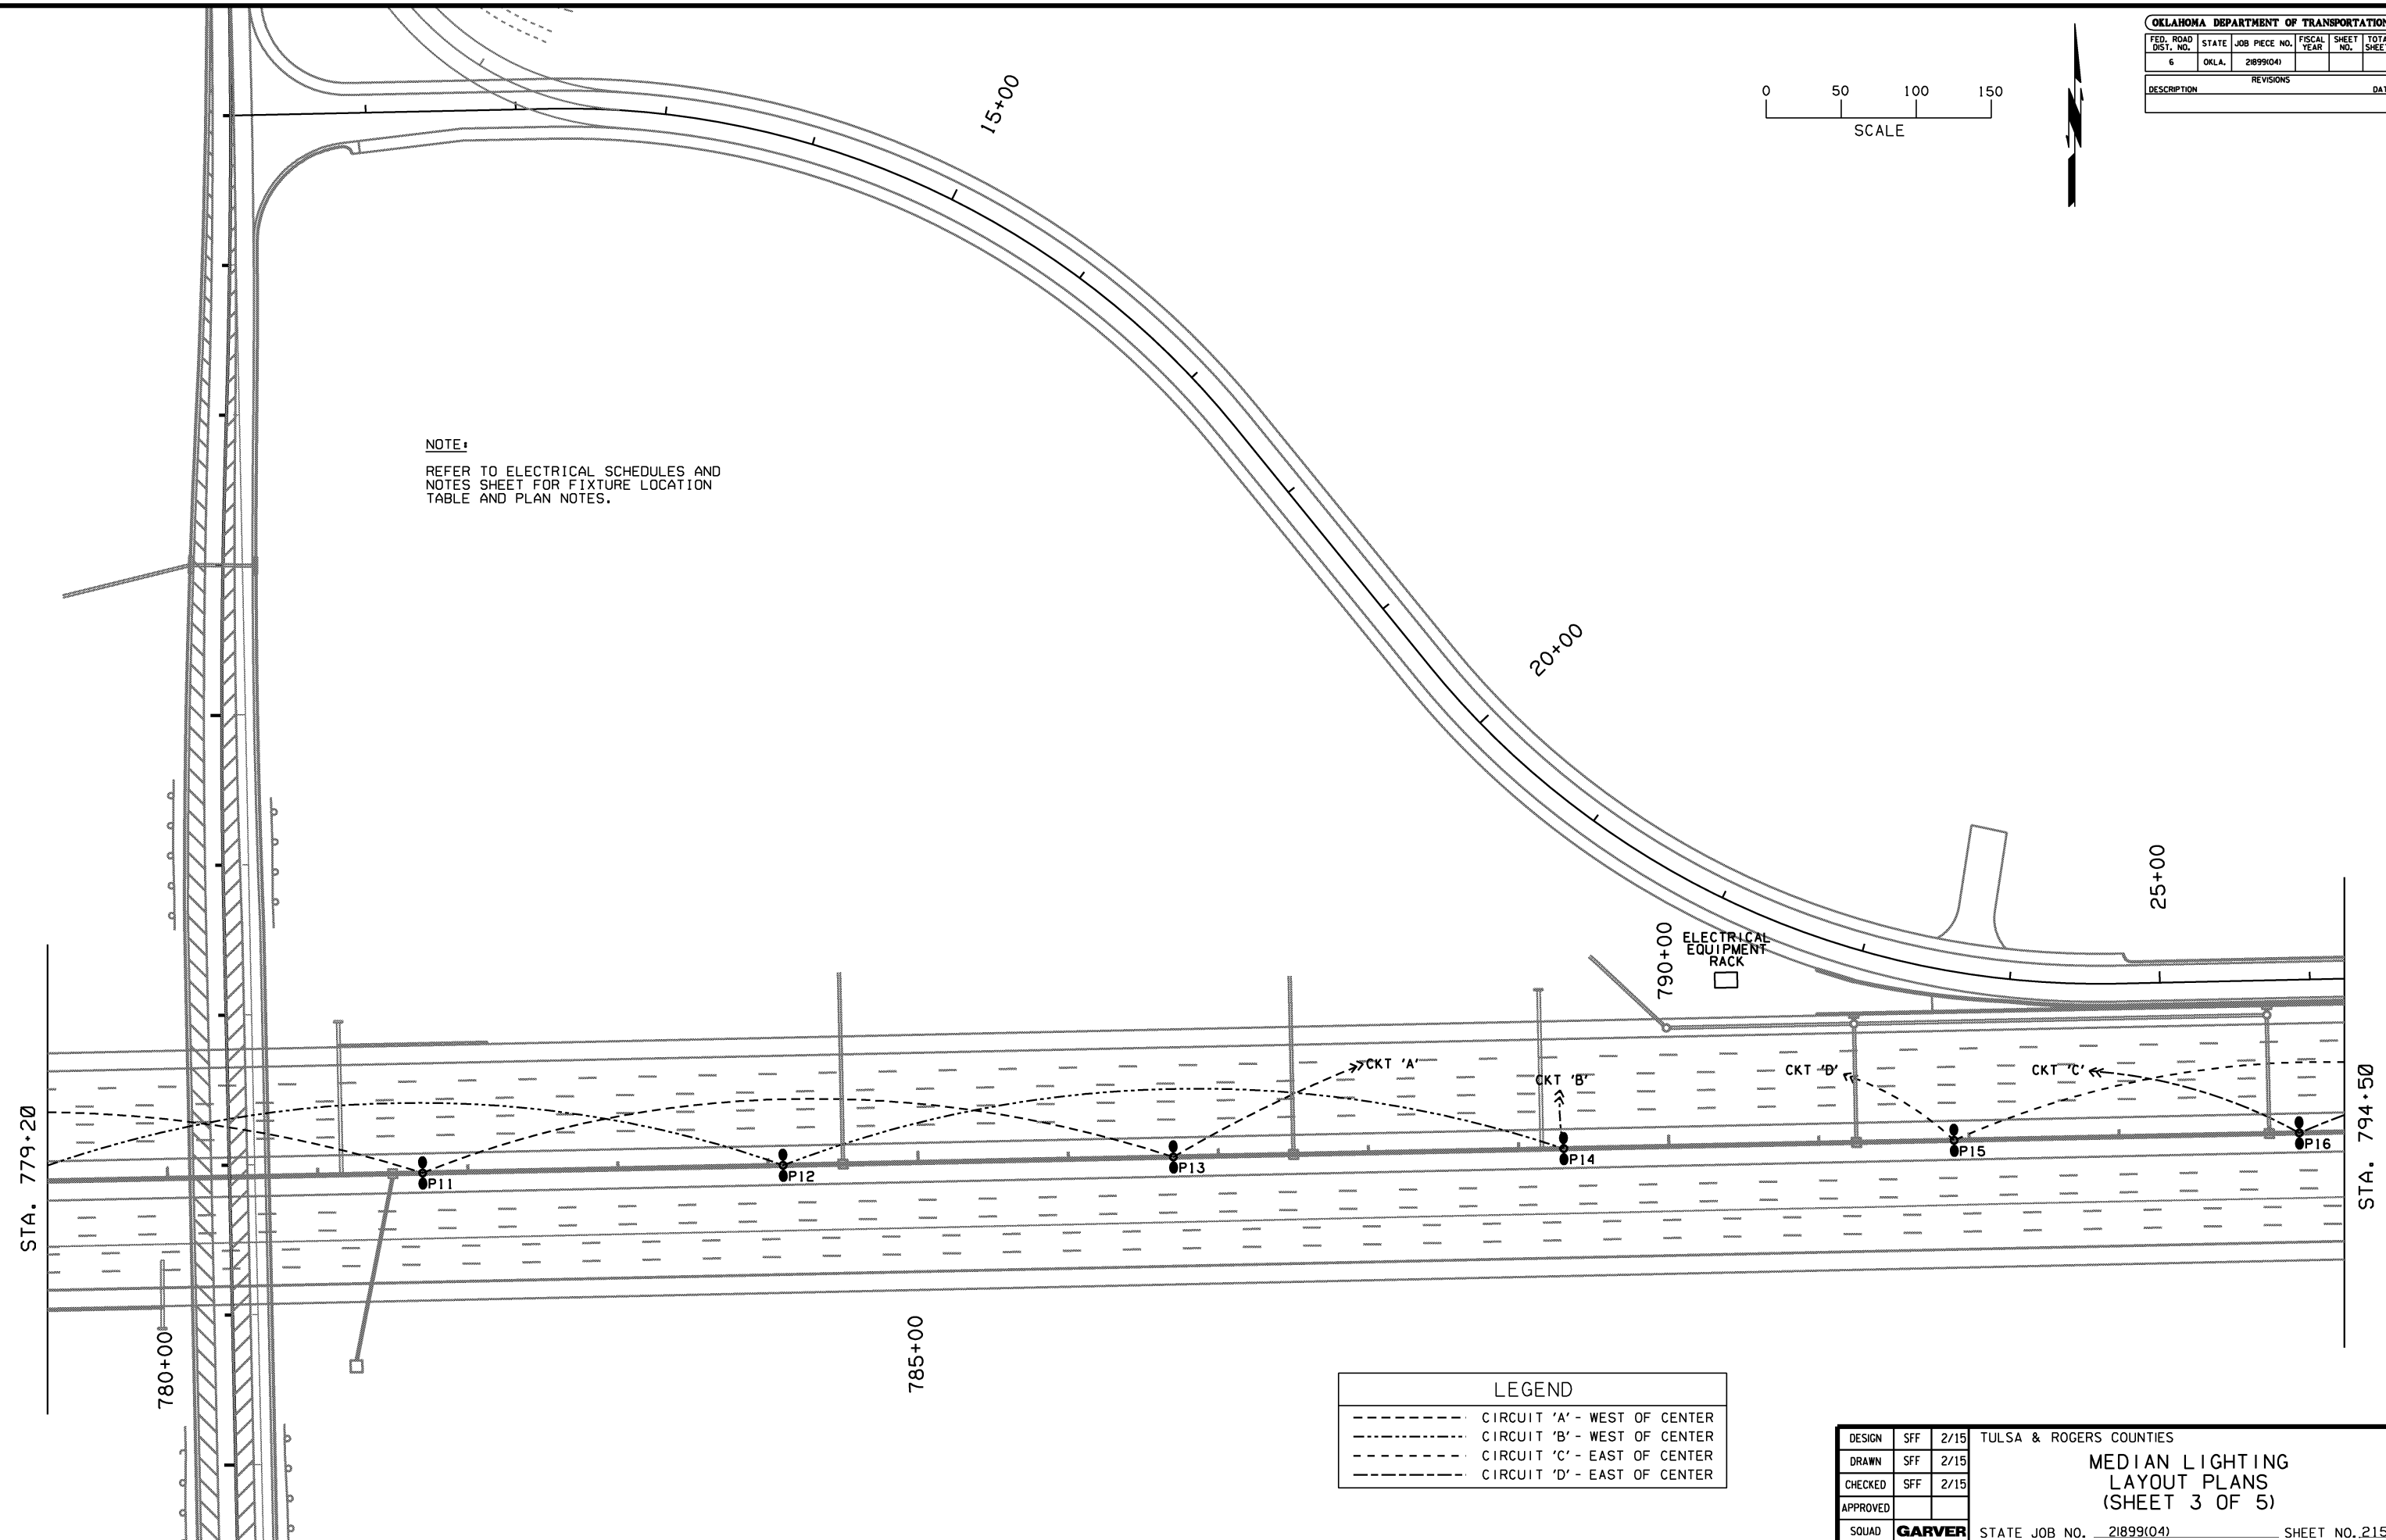

LEGEND	
-----	CIRCUIT 'A' - WEST OF CENTER
-----	CIRCUIT 'B' - WEST OF CENTER
-----	CIRCUIT 'C' - EAST OF CENTER
-----	CIRCUIT 'D' - EAST OF CENTER

DESIGN	SFF	2/15	TULSA & ROGERS COUNTIES
DRAWN	SFF	2/15	MEDIAN LIGHTING LAYOUT PLANS (SHEET 3 OF 5)
CHECKED	SFF	2/15	
APPROVED			
SQUAD	GARVER	STATE JOB NO. 21899(04)	SHEET NO. 215