 



OKLAHOMA DEPARTMENT OF TRANSPORTATION					
FED. ROAD DIST. NO.	STATE	JOB PIECE NO.	FISCAL YEAR	SHEET NO.	TOTAL SHEETS
6	OKLA.	21899(04)			
DESCRIPTION			REVISIONS	DATE	



NOTE:  
REFER TO ELECTRICAL SCHEDULES AND NOTES SHEET FOR FIXTURE LOCATION TABLE AND PLAN NOTES.

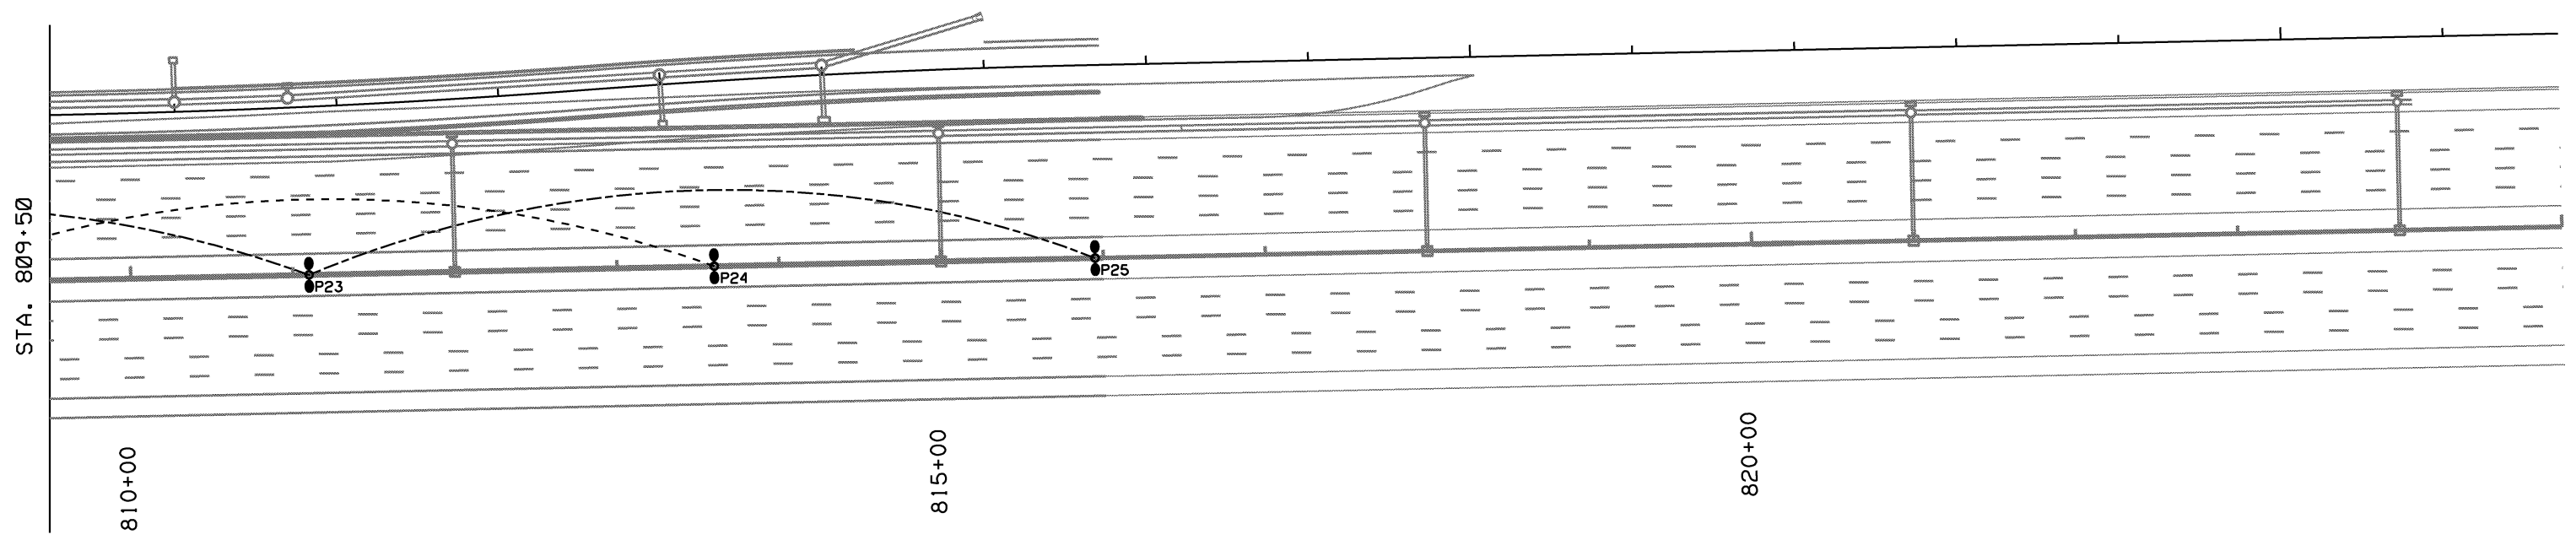

LEGEND	
-----	CIRCUIT 'C' - EAST OF CENTER
- . - . - .	CIRCUIT 'D' - EAST OF CENTER

DESIGN	SFF	2/15	TULSA & ROGERS COUNTIES
DRAWN	SFF	2/15	<b>MEDIAN LIGHTING LAYOUT PLANS (SHEET 5 OF 5)</b>
CHECKED	SFF	2/15	
APPROVED			
SQUAD	<b>GARVER</b>	STATE JOB NO. 21899(04)	SHEET NO. 217