 



OKLAHOMA DEPARTMENT OF TRANSPORTATION					
FED. ROAD DIST. NO.	STATE	JOB PIECE NO.	FISCAL YEAR	SHEET NO.	TOTAL SHEETS
6	OKLA.	21899(04)			
DESCRIPTION			REVISIONS	DATE	



**NOTE:**  
REFER TO ELECTRICAL SCHEDULES AND NOTES SHEET FOR PULLBOX SCHEDULE AND PLAN NOTES.

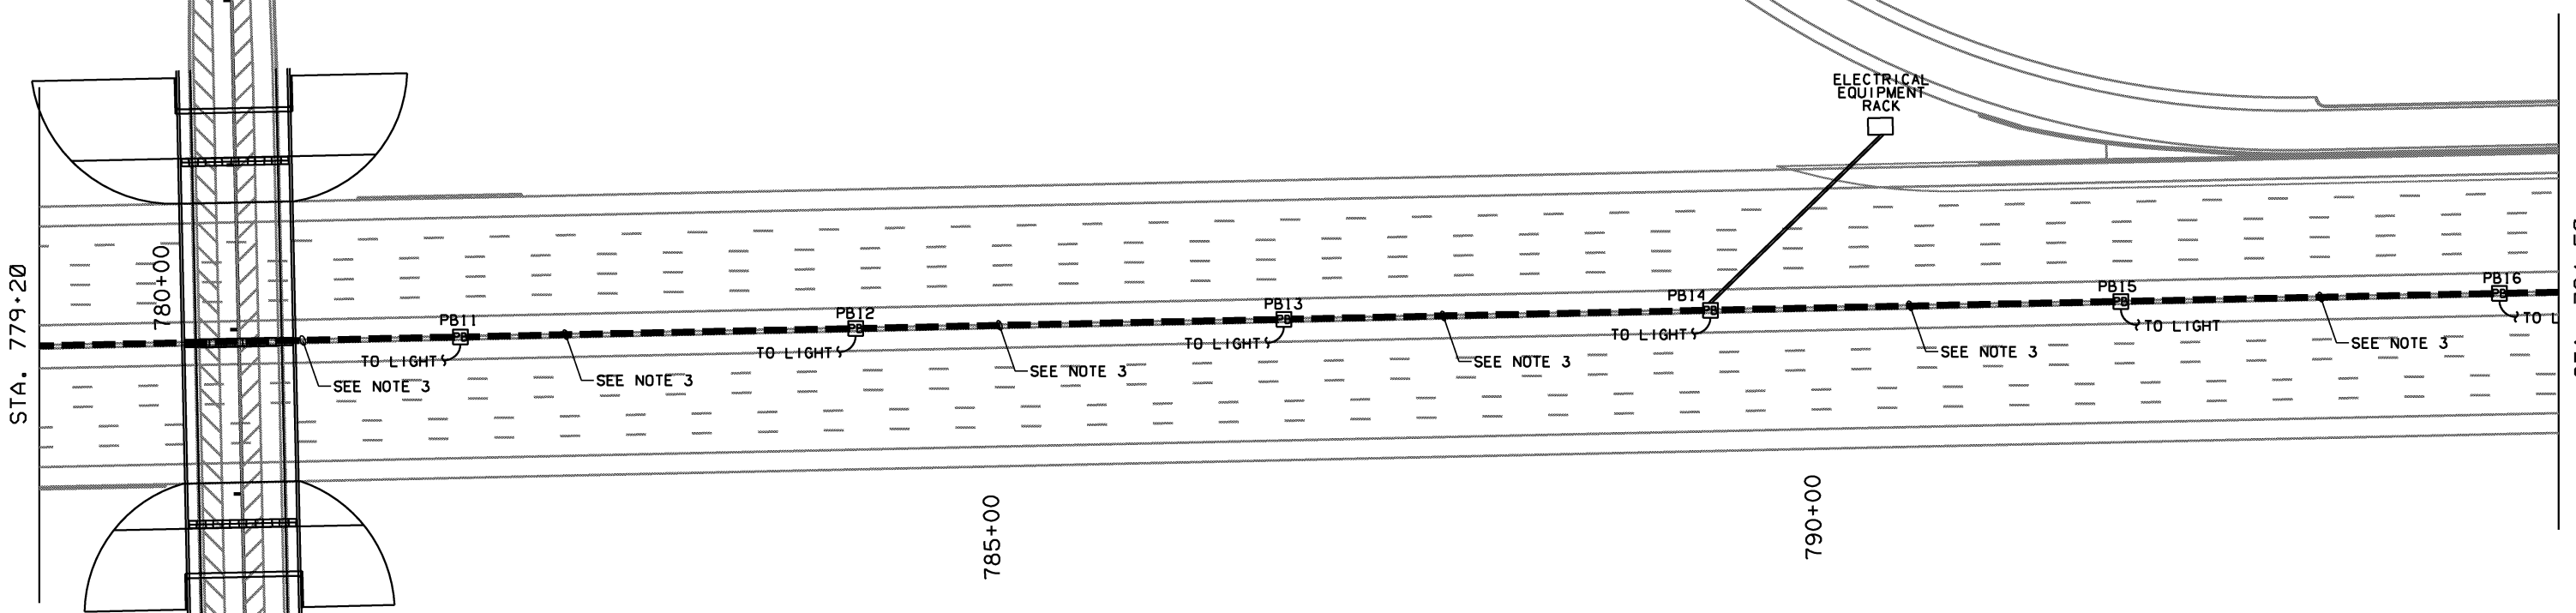

DESIGN	SFF	2/15	TULSA & ROGERS COUNTIES
DRAWN	SFF	2/15	<b>MEDIAN LIGHTING CONDUIT ROUTING PLANS (SHEET 3 OF 5)</b>
CHECKED	SFF	2/15	
APPROVED			
SQUAD	<b>GARVER</b>	STATE JOB NO. 21899(04)	SHEET NO. 221