
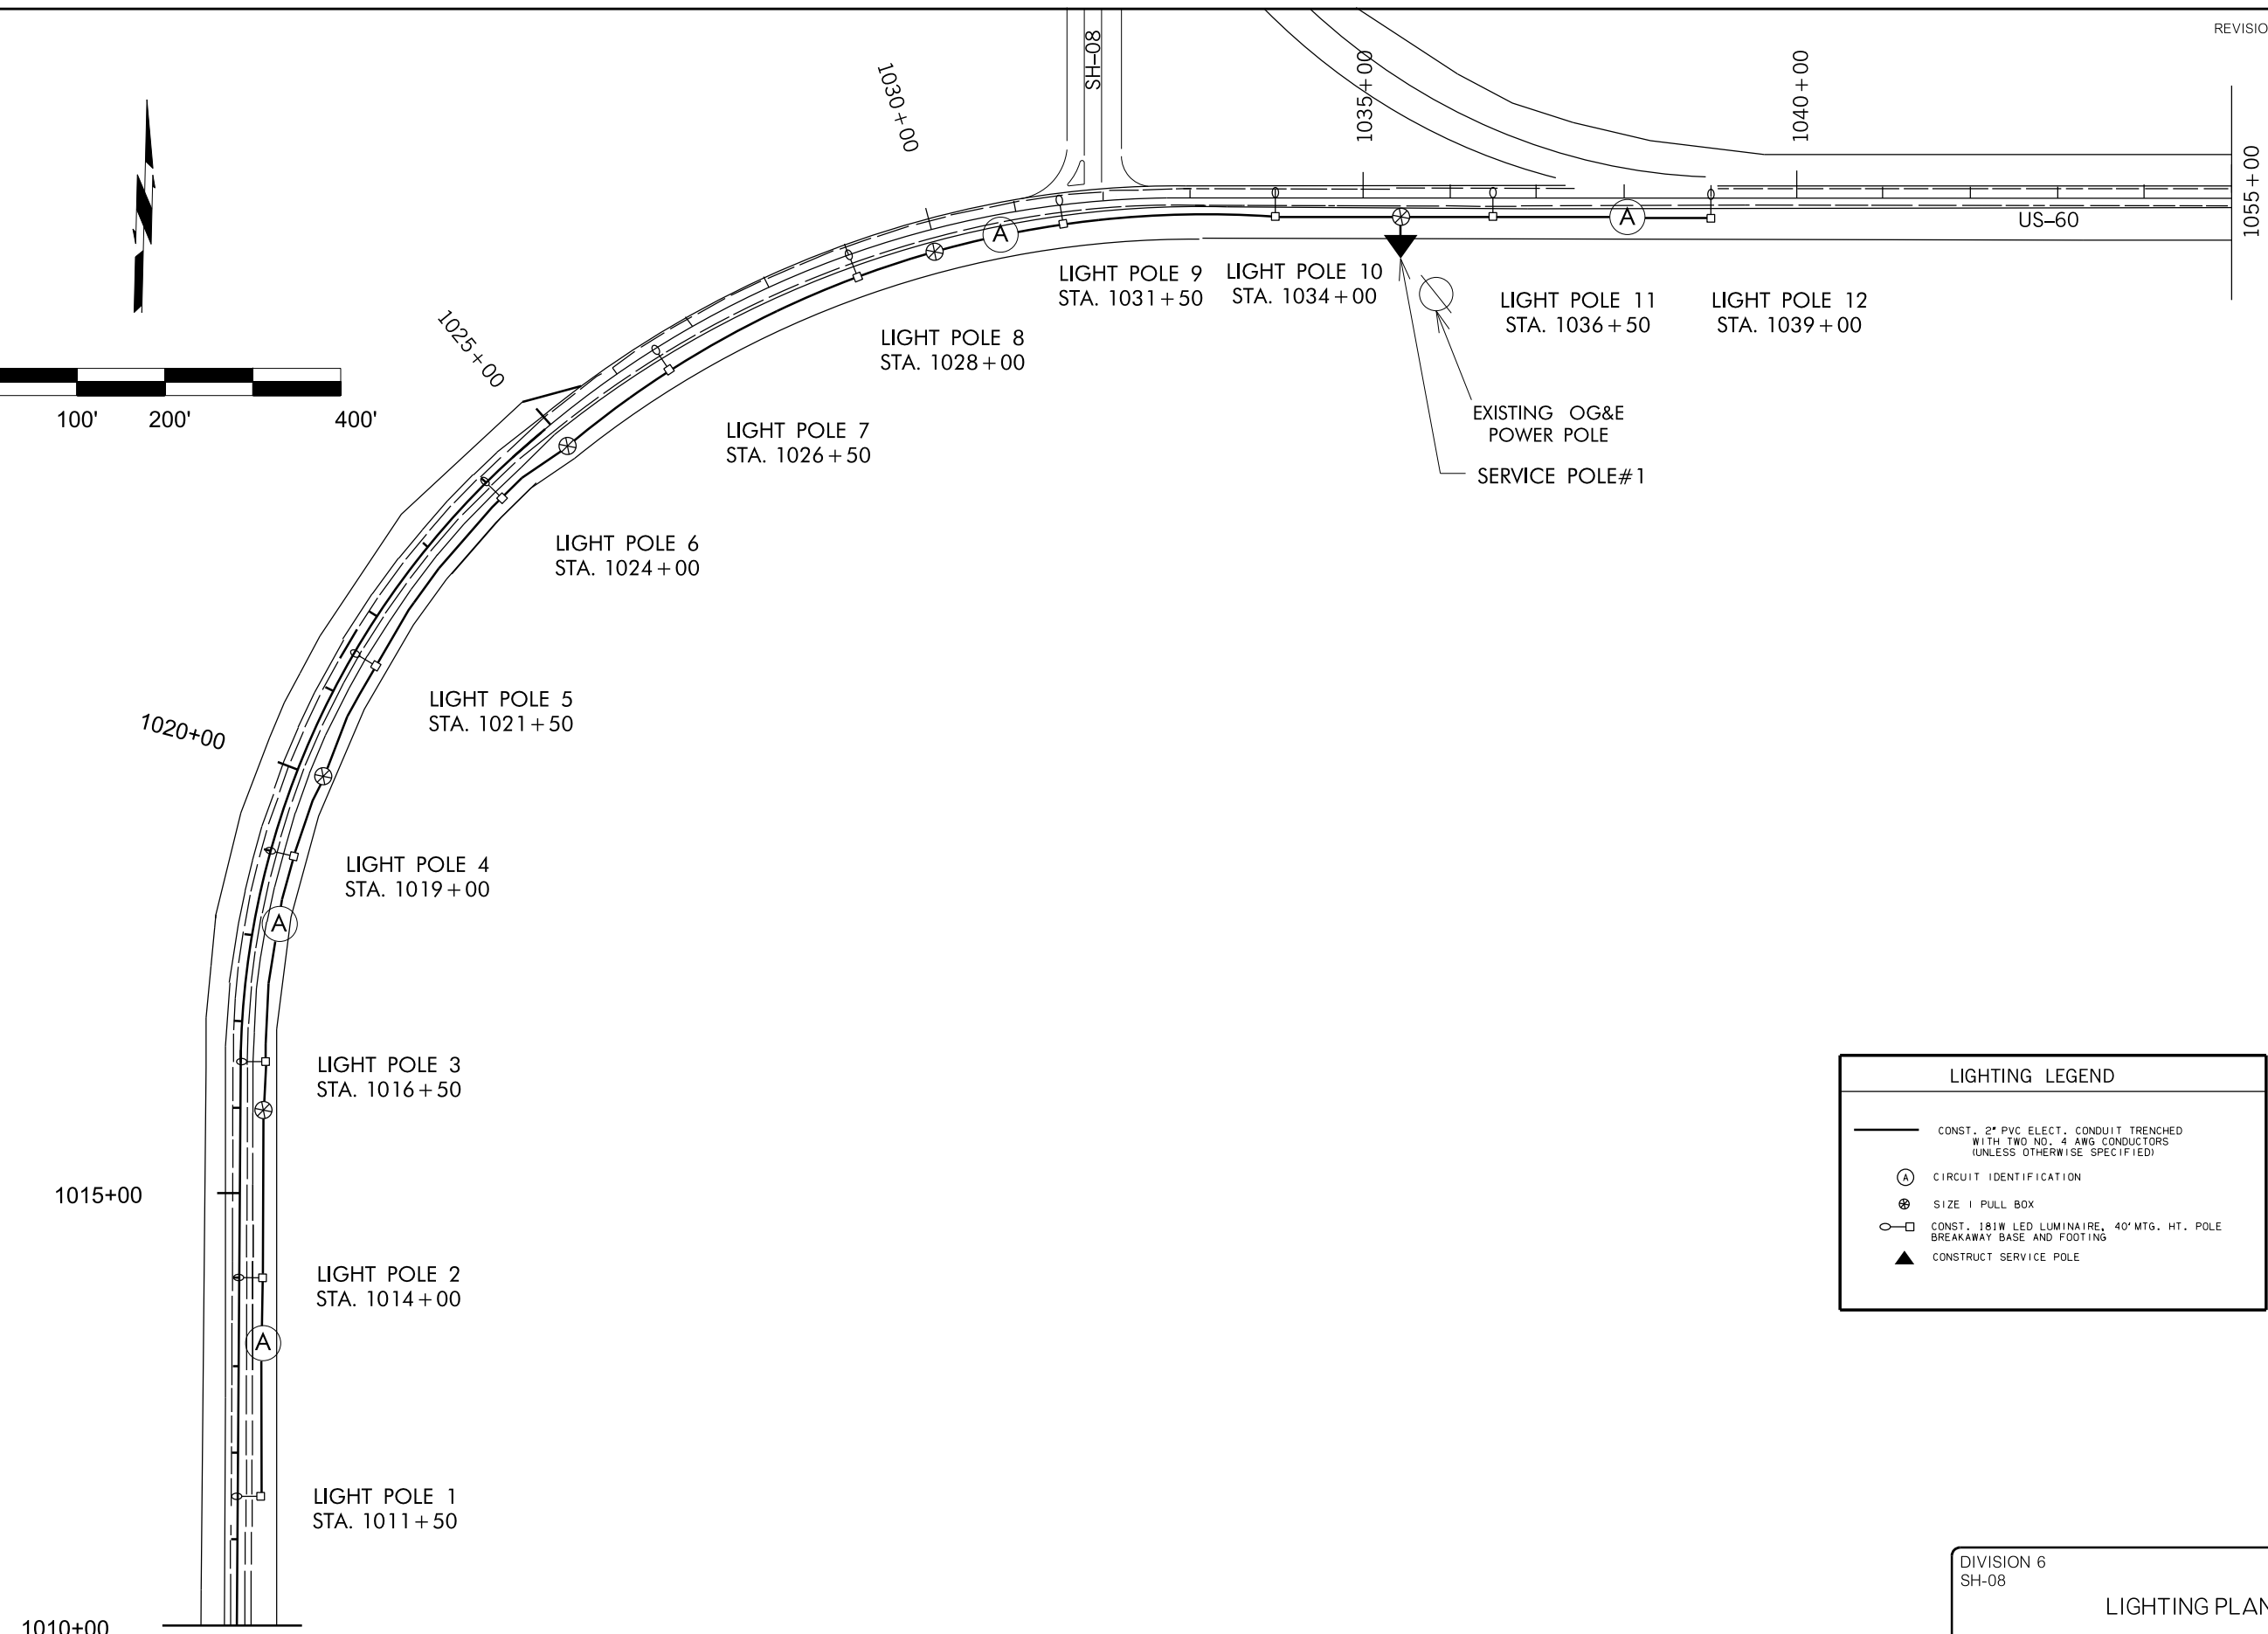


REVISIONS		REVISIONS	
REV. NO.	DESCRIPTION	REV. NO.	DATE

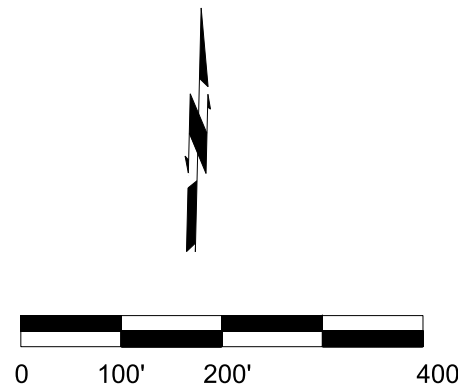

LIGHTING LEGEND	
	CONST. 2" PVC ELECT. CONDUIT TRENCHED WITH TWO NO. 4 AWG CONDUCTORS (UNLESS OTHERWISE SPECIFIED)
	CIRCUIT IDENTIFICATION
	SIZE 1 PULL BOX
	CONST. 181W LED LUMINAIRE, 40' MTG. HT. POLE BREAKAWAY BASE AND FOOTING
	CONSTRUCT SERVICE POLE

DIVISION 6 SH-08	MAJOR COUNTY	DETAIL:	SRW	5/17
LIGHTING PLAN		CHECK:	JLS	5/17
		ENGINEER:	SEB	5/17
STATE OF OKLAHOMA		GROUP: WILLIAMS EM: SHORT		
DEPARTMENT OF TRANSPORTATION		JOB/PIECE NO. 27005(07)	SHEET NO. T001	